


SYMBOLS

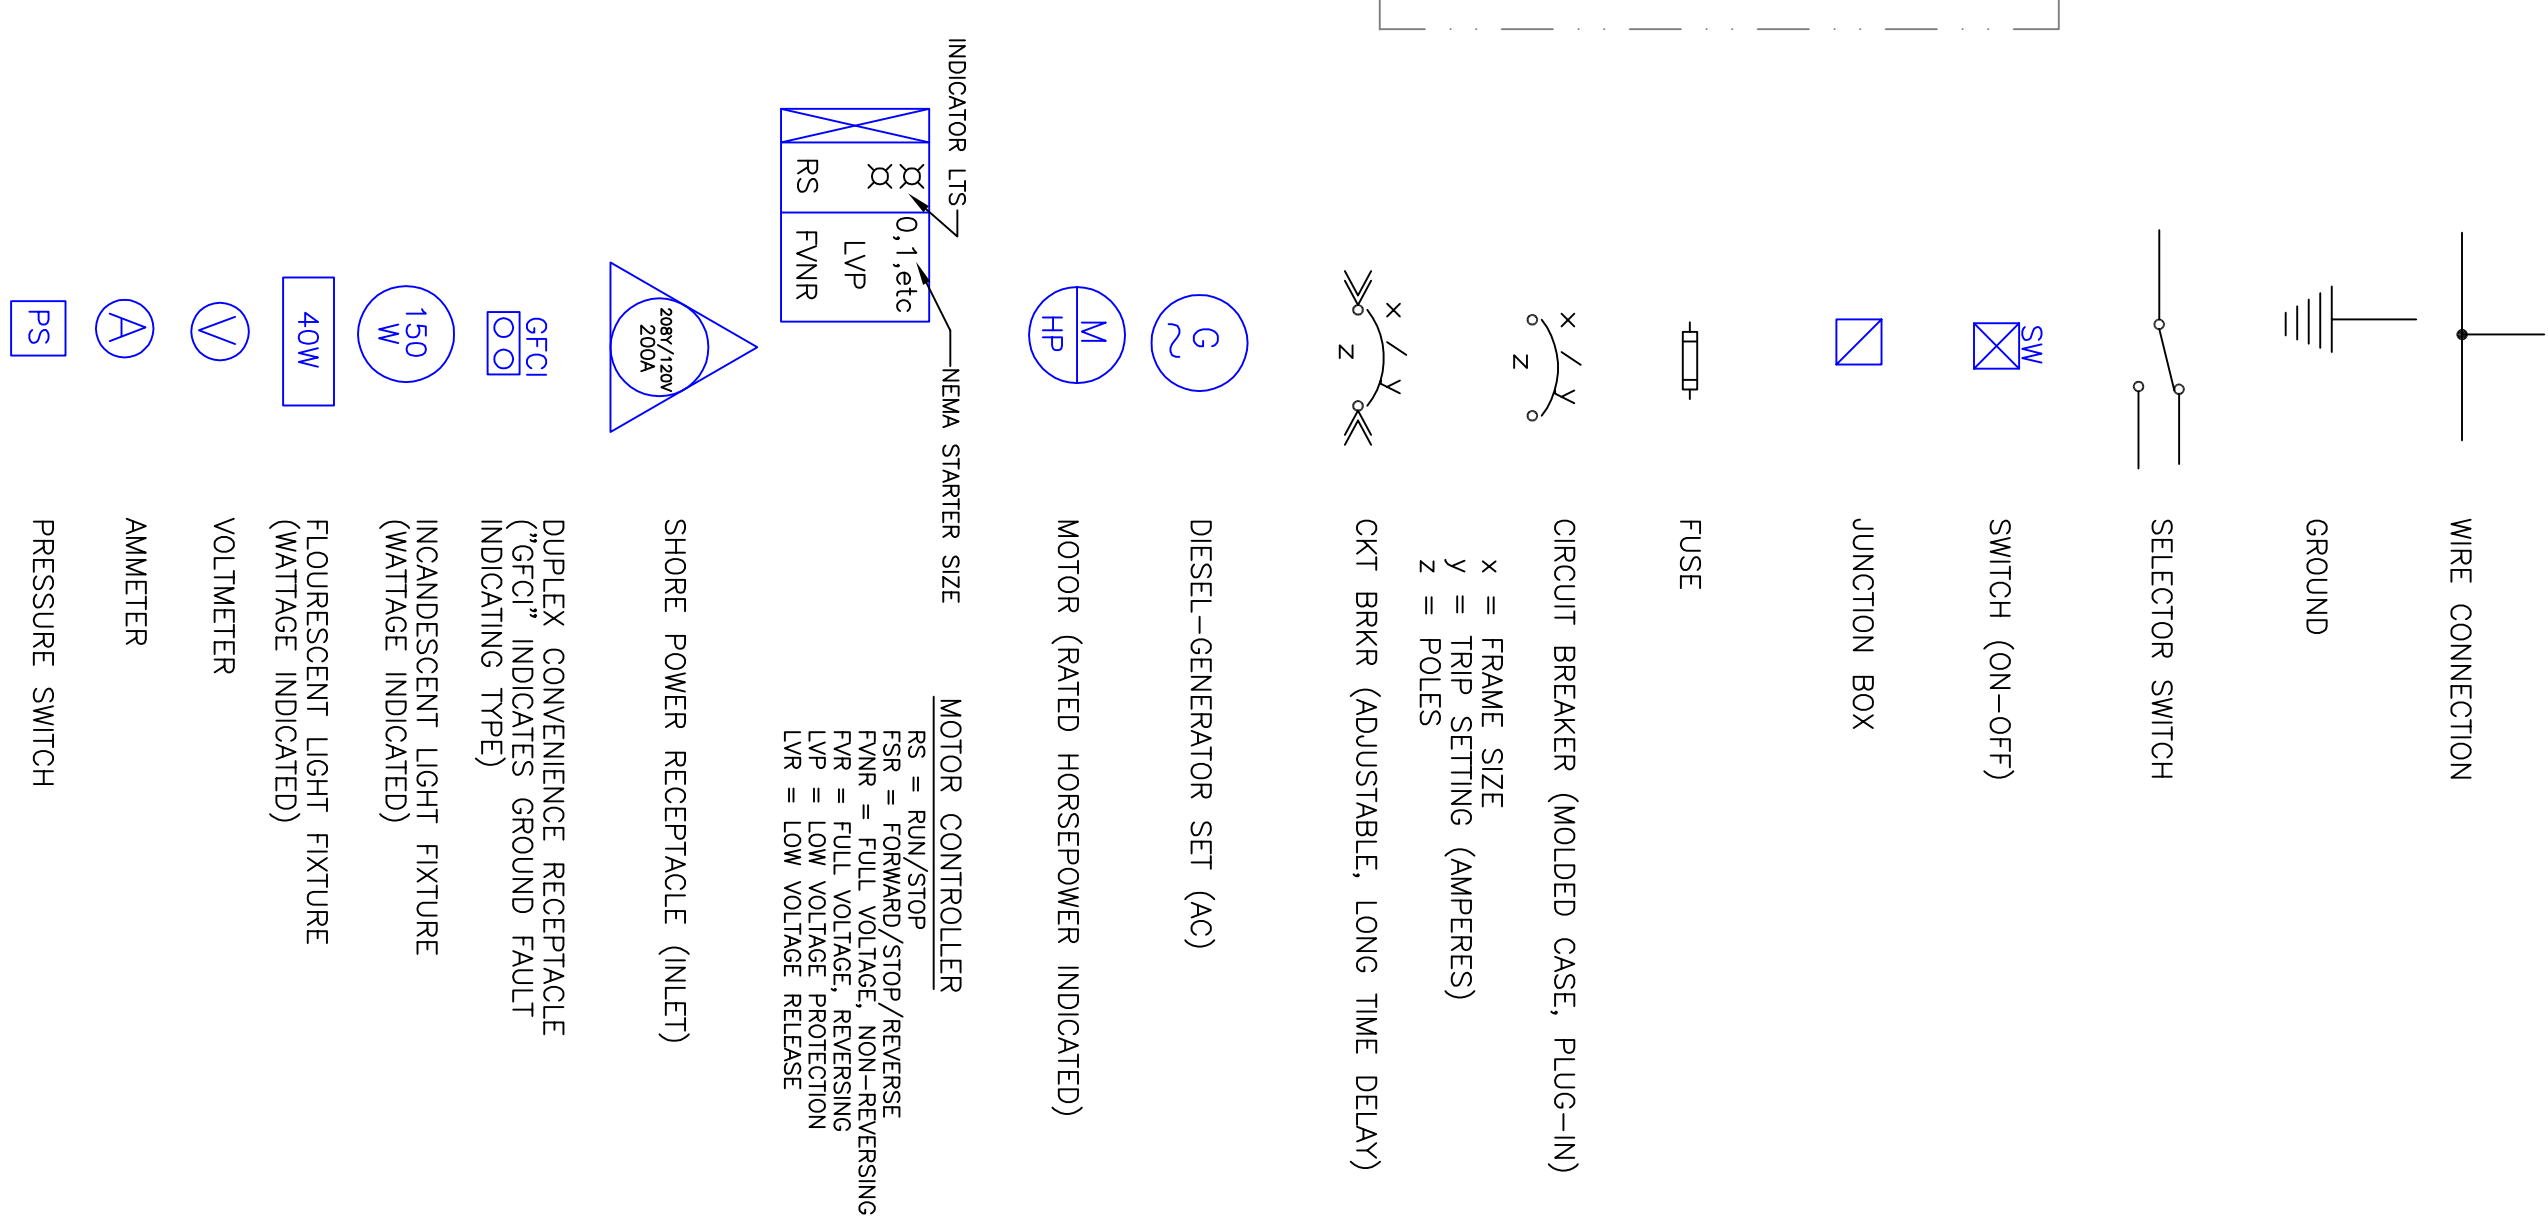

REFERENCES

1. One2Three Pty Ltd DWG No.0534--00016 130 FT MONOHULL (6/29/06)
2. Gaylord Industries DWG No.06--1122



ALAN WINKLEY NAVAL ARCHITECTURE, LLC
 1367 Jacobsen Boulevard
 Bremerton, Washington 98310
 (360) 373-8361

VENETIAN LADY

208Y/120 VAC ELECTRICAL SYSTEM
ONE-LINE DIAGRAM

FOR	ISLAND BOATS INC.
SCALE	NONE
DATE	AUGUST 3, 2006
DRAWN BY	ALAN WINKLEY, P.E.
DWG No.	3606-4
REV	SHEET 1/4

The information contained in this drawing has been prepared and reviewed by me and is certified as complying with U.S. Coast Guard regulations [46 CFR Part 183].

KEY TO PUMP DESIGNATIONS:
 "P1" - CHILLED WATER PUMP FOR AIR CONDITIONING
 "P2" - CONDENSER COOLING (CW) PUMP FOR AIR CONDITIONING
 "P3" - SEAWATER COOLING PUMP FOR AIR CONDITIONING